


SYMBOLS AND LIFESTYLES KEY	
SYMBOL	DESCRIPTION
	COMMUNICATIONS CONDUIT, UNIVERSITY OWNED
	COMMUNICATIONS CONDUIT, OTHER UTILITY OWNED
	COMMUNICATIONS UNDERGROUND ABANDONED - SU
	COMMUNICATIONS DUCTBANK
	COMMUNICATIONS DUCTBANK
	COMMUNICATIONS OVERHEAD, UNIVERSITY OWNED
	COMMUNICATIONS OVERHEAD, OTHER UTILITY OWNED
	COMMUNICATIONS UNDERGROUND VERIZON
	COMMUNICATIONS VERIZON ABANDONED
	COMMUNICATIONS UNDERGROUND UNIVERSITY BLUE LIGHT, PANIC BUTTON, ETC.
	COMMUNICATIONS UNDERGROUND UNIVERSITY - CAMERA
	INTERIOR PULLBOX AND INTERIOR PATHWAY
	INTERIOR PULLBOX AND INTERIOR PATHWAY UNDER SLAB OR IN CRAWLSPACE

SITE PLAN ABBREVIATIONS	
BLS	EMERGENCY BLUE LIGHT STANDARD
CCTV	CLOSED CIRCUIT TELEVISION
HH	HAND HOLE
ISP	INSIDE PLANT
MTR	MAIN TELECOMMUNICATIONS ROOM
OSP	OUTSIDE PLANT
SU	SYRACUSE UNIVERSITY
TR	TELECOMMUNICATIONS ROOM
UG	UNDERGROUND
VIF	VERIFY IN FIELD
XVA	COMMUNICATIONS VERIZON ABANDONED
XCO	COMMUNICATIONS CONDUIT, OTHER UTILITY OWNED
XCU	COMMUNICATIONS CONDUIT, UNIVERSITY OWNED
XDB	COMMUNICATIONS DUCTBANK
XMU	COMMUNICATIONS MANHOLE
XOU	COMMUNICATIONS OVERHEAD, UNIVERSITY OWNED
XOO	COMMUNICATIONS OVERHEAD, OTHER UTILITY OWNED
XUA	COMMUNICATIONS UNDERGROUND ABANDONED - SU
XUB	COMMUNICATIONS UNDERGROUND ABANDONED - VERIZON
XUV	COMMUNICATIONS UNDERGROUND VERIZON
XUU	COMMUNICATIONS UNDERGROUND UNIVERSITY


COMMON PATHWAY DESIGNATORS	
C.I.	CAST IRON
CLAY	VITRIFIED CLAY CONDUIT (SINGLE ROUND DUCT)
DB	DIRECT BURIED
FAC	FREE AIR CABLE
GALV	RIGID GALVANIZED STEEL
HDPE	HIGH DENSITY POLYETHYLENE DUCT
MCD	MULTIPLE CLAY DUCT (SQUARE DUCTS)
OFD	ORANGEBURG FIBROUS DUCT
PVC	POLYVINYL CHLORIDE DUCT
RGS	RIGID GALVANIZED STEEL

UTILITY DESIGNATORS	
NG	NATIONAL GRID (ELECTRIC)
NM	NIAGARA-MOHAWK (ELECTRIC)
TW	TIME WARNER (COMMUNICATIONS)
VZ	VERIZON (COMMUNICATIONS)

NOTE: "XMU-" PREFIX NOT SHOWN AT MANHOLES FOR CLARITY.

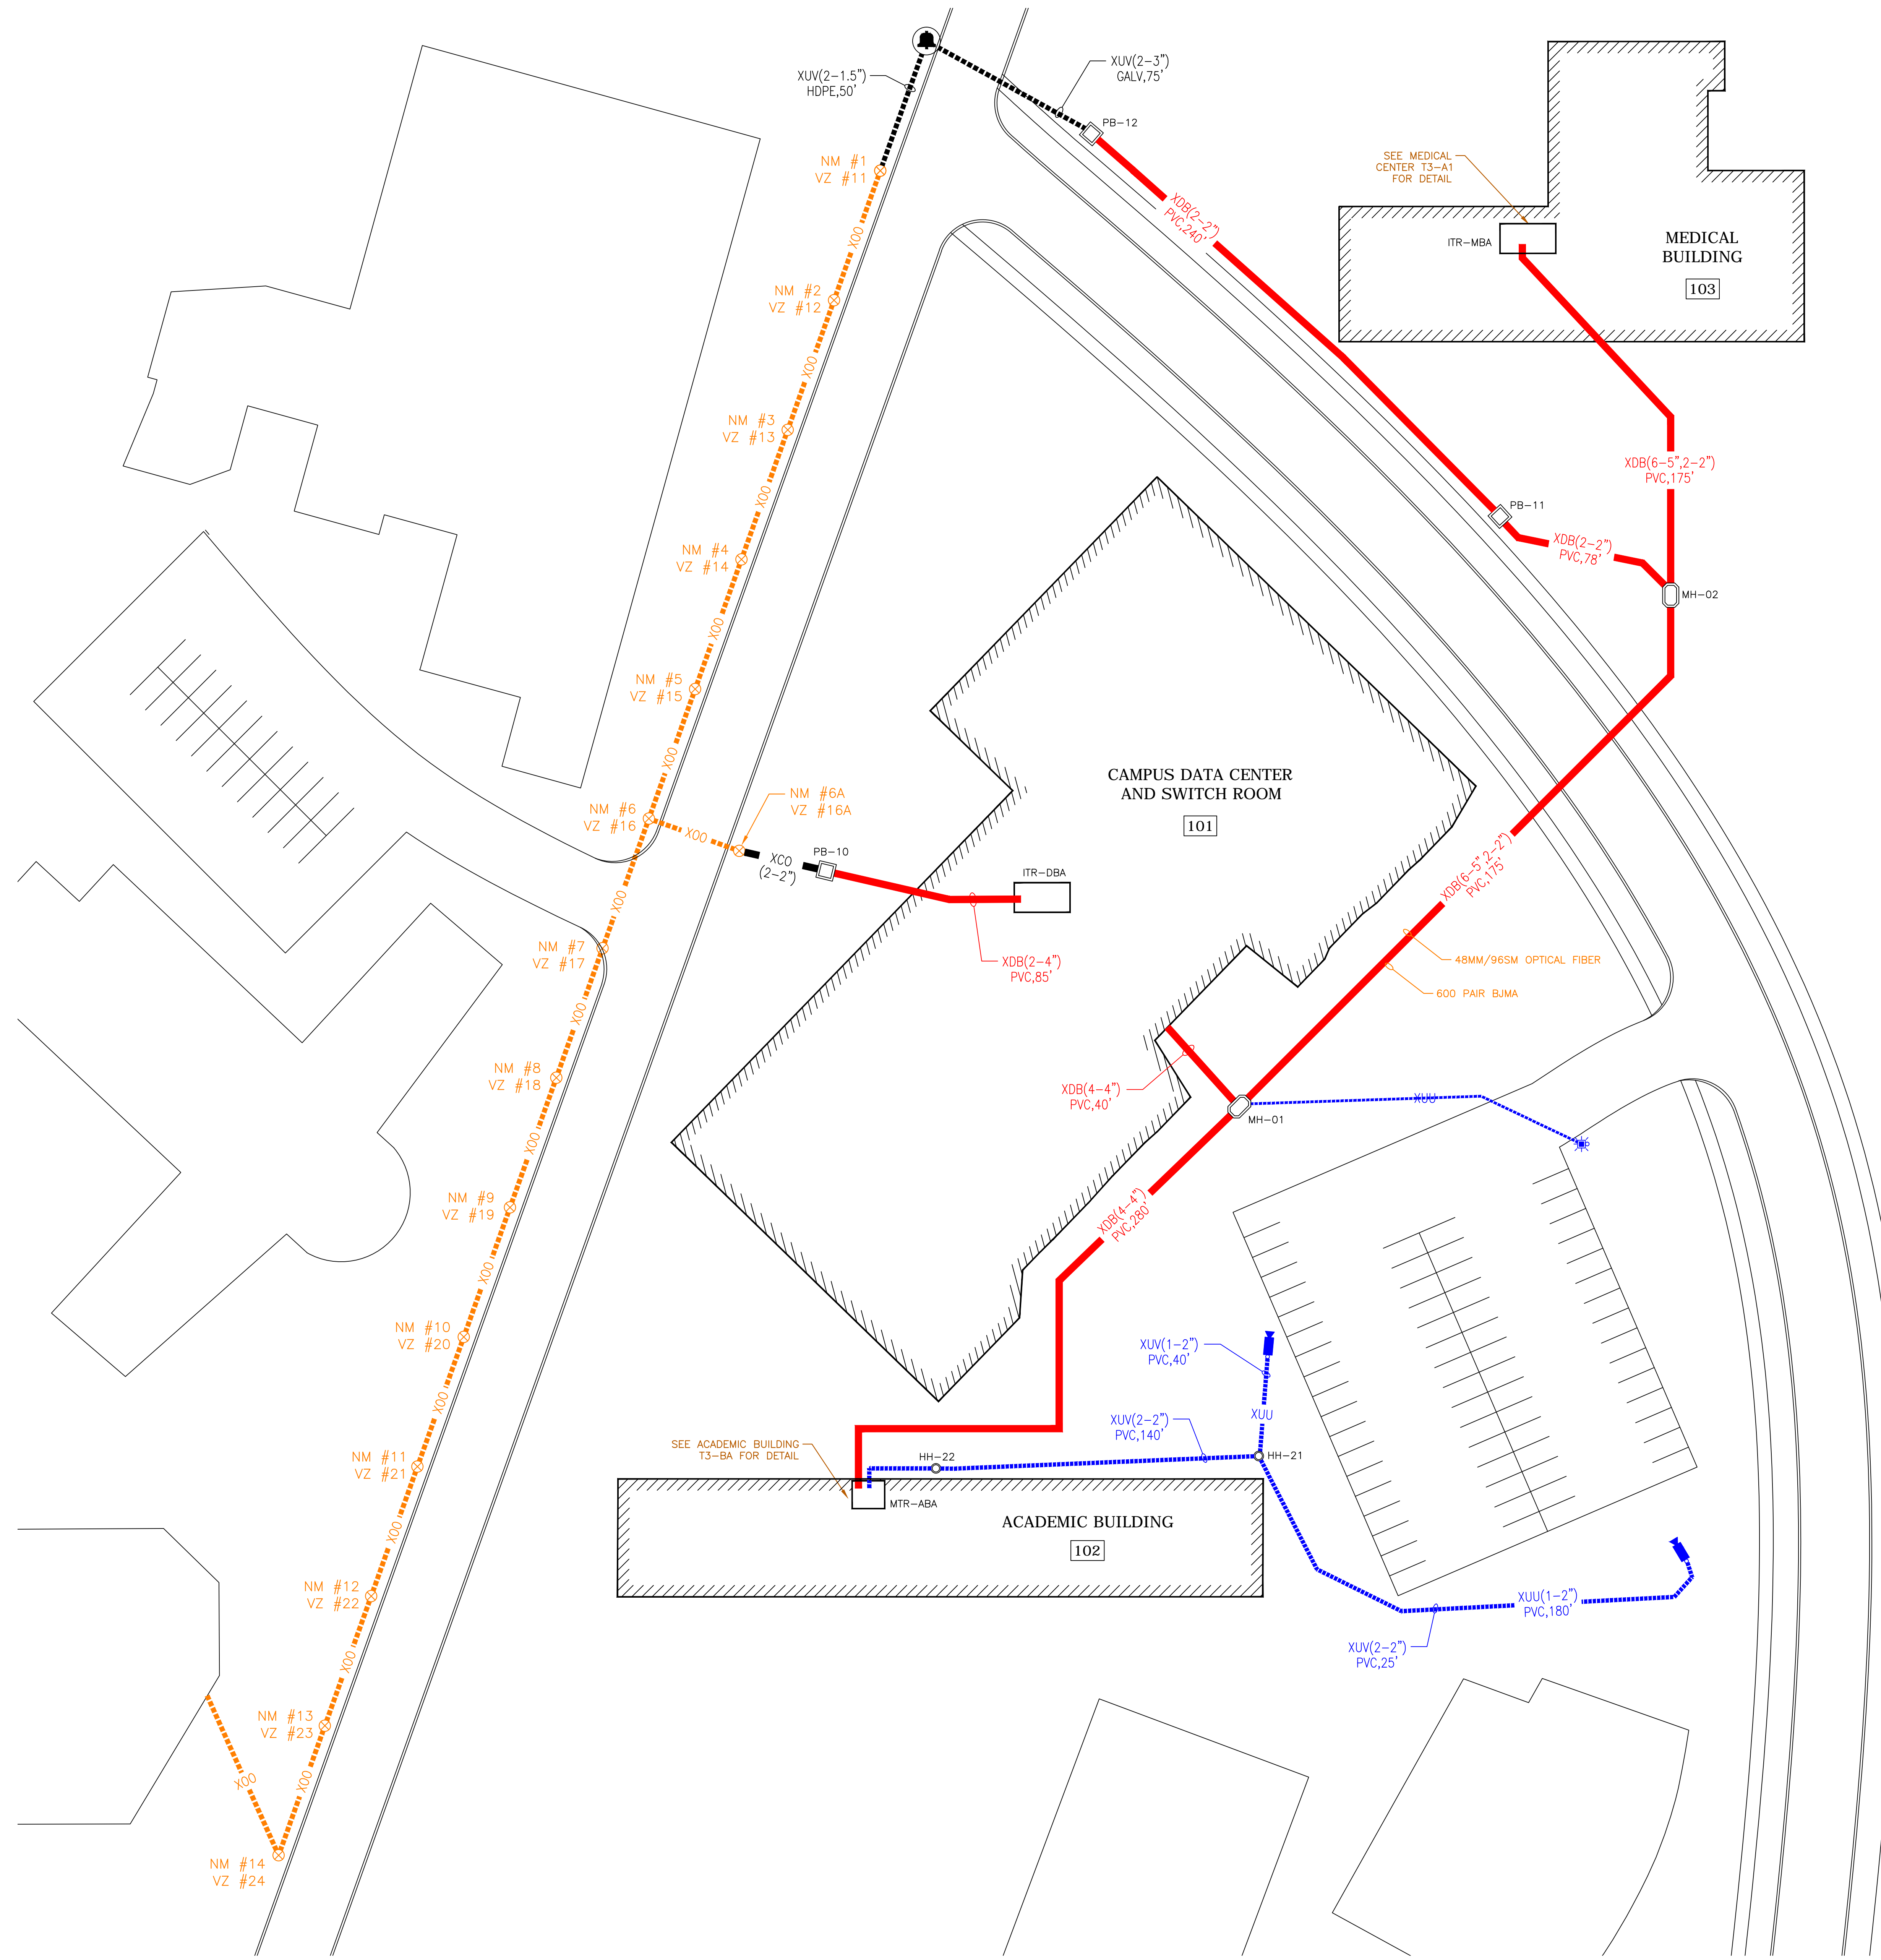

1 SITE PLAN - COMMUNICATIONS PATHWAYS & CABLING
Scale: 1/32" = 1'-0"

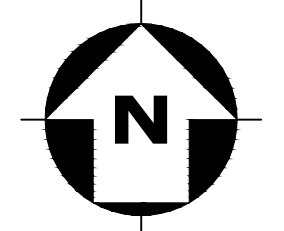

CLIENT:

MARK	DATE	DESCRIPTION
△	7/19/2013	FO-01-PROVIDE INNERDUCT

OSP SITE EFR SAMPLE

ISSUE DATE: 1-15-15

AT PROJECT NO:	1234
OWNER PROJECT NO:	
DRAWN BY:	EL
CHECKED BY:	MH
PROJECT MANAGER:	MH

SHEET TITLE:

SITE PLAN

T0-1.CA_CP